

GENERAL NOTES

- 1 Do not scale off this drawing - work to figured dimensions only.
- 2 Check all dimensions and levels on site before commencing work.
- 3 Report any discrepancies to the supervising engineer and obtain instructions.
- 4 Bahrain construction specification applies.
- 5 Contractor to provide necessary sample/mock-up for all the material, finishes as stated for d-interiors approval.

NOTE:

- All dimensions in millimeter unless otherwise stated.
- All lighting fixtures & switches locations to be marked at site for id's approval
- HVAC, Electrical, Plumbing, AV System, Fire Protection, Kitchen Equipment and any related Specialty Works and requirements shall be conformed by the respective duly MEP & Auxiliary Consultant.

| | | |
|-----|----------|------|
| NO. | REVISION | DATE |
|-----|----------|------|

CLIENT
ISA ALSHOMLY

PROJECT
DOHA ARAD
MUHARRAQ, KINGDOM OF BAHRAIN

DRAWING
FITSPACE GYM

SCALE : AS SHOWN
DATE : 19.09.2024
DESIGNER : AHMED SUBAH
CHECKED :


IS-ID-01

1

MASTER PLAN

SCALE

1:50

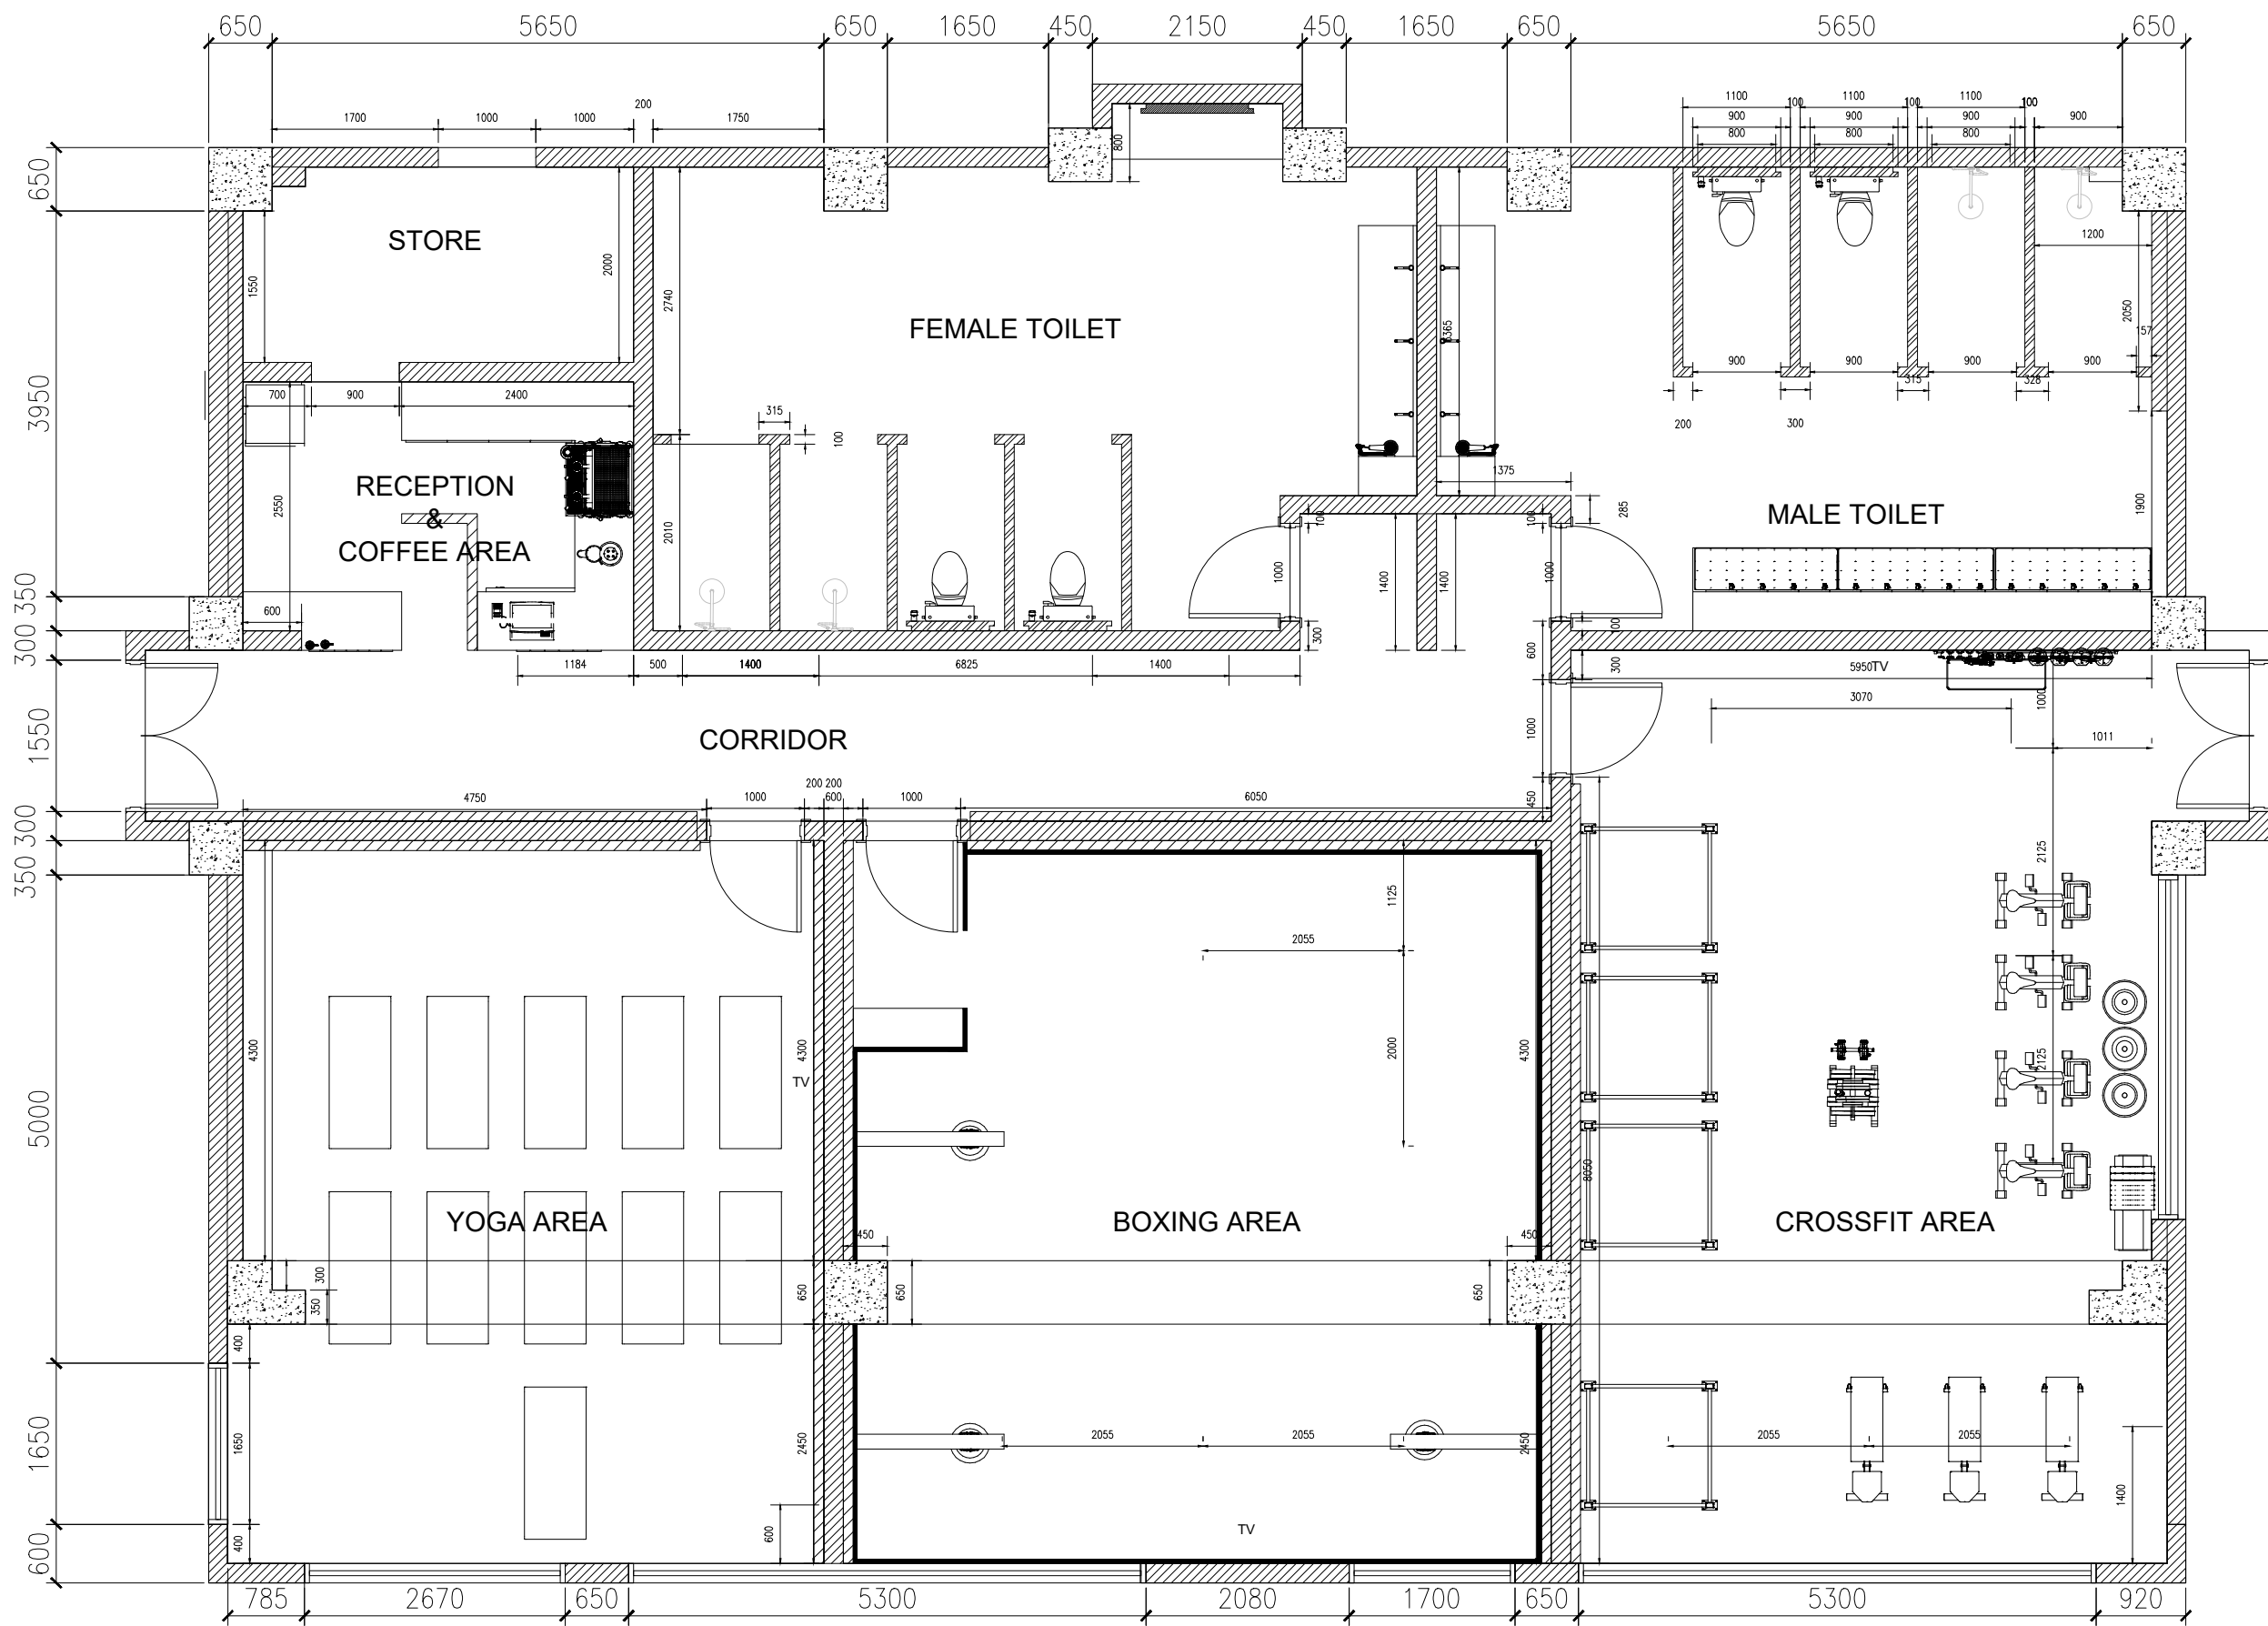

GENERAL NOTES

- 1 Do not scale off this drawing - work to figured dimensions only.
- 2 Check all dimensions and levels on site before commencing work.
- 3 Report any discrepancies to the supervising engineer and obtain instructions.
- 4 Bahrain construction specification applies.
- 5 Contractor to provide necessary sample/mock-up for all the material, finishes as stated for d-interiors approval.

NOTE:

- All dimensions in millimeter unless otherwise stated.
- All lighting fixtures & switches locations to be marked at site for id's approval
- HVAC, Electrical, Plumbing, AV System, Fire Protection, Kitchen Equipment and any related Specialty Works and requirements shall be conformed by the respective duly MEP & Auxiliary Consultant.

| NO. | REVISION | DATE |
|-----|----------|------|
|-----|----------|------|

CLIENT

ISA ALSHOMLY

PROJECT

DOHA ARAD
MUHARRAQ, KINGDOM of BAHRAIN

DRAWING

FITSPACE GYM


| | |
|------------------------|----------|
| SCALE : AS SHOWN | IS-ID-02 |
| DATE : 19.09.2024 | |
| DESIGNER : AHMED SUBAH | |
| CHECKED : | |

2

FURNITURE PLAN

SCALE

1:50

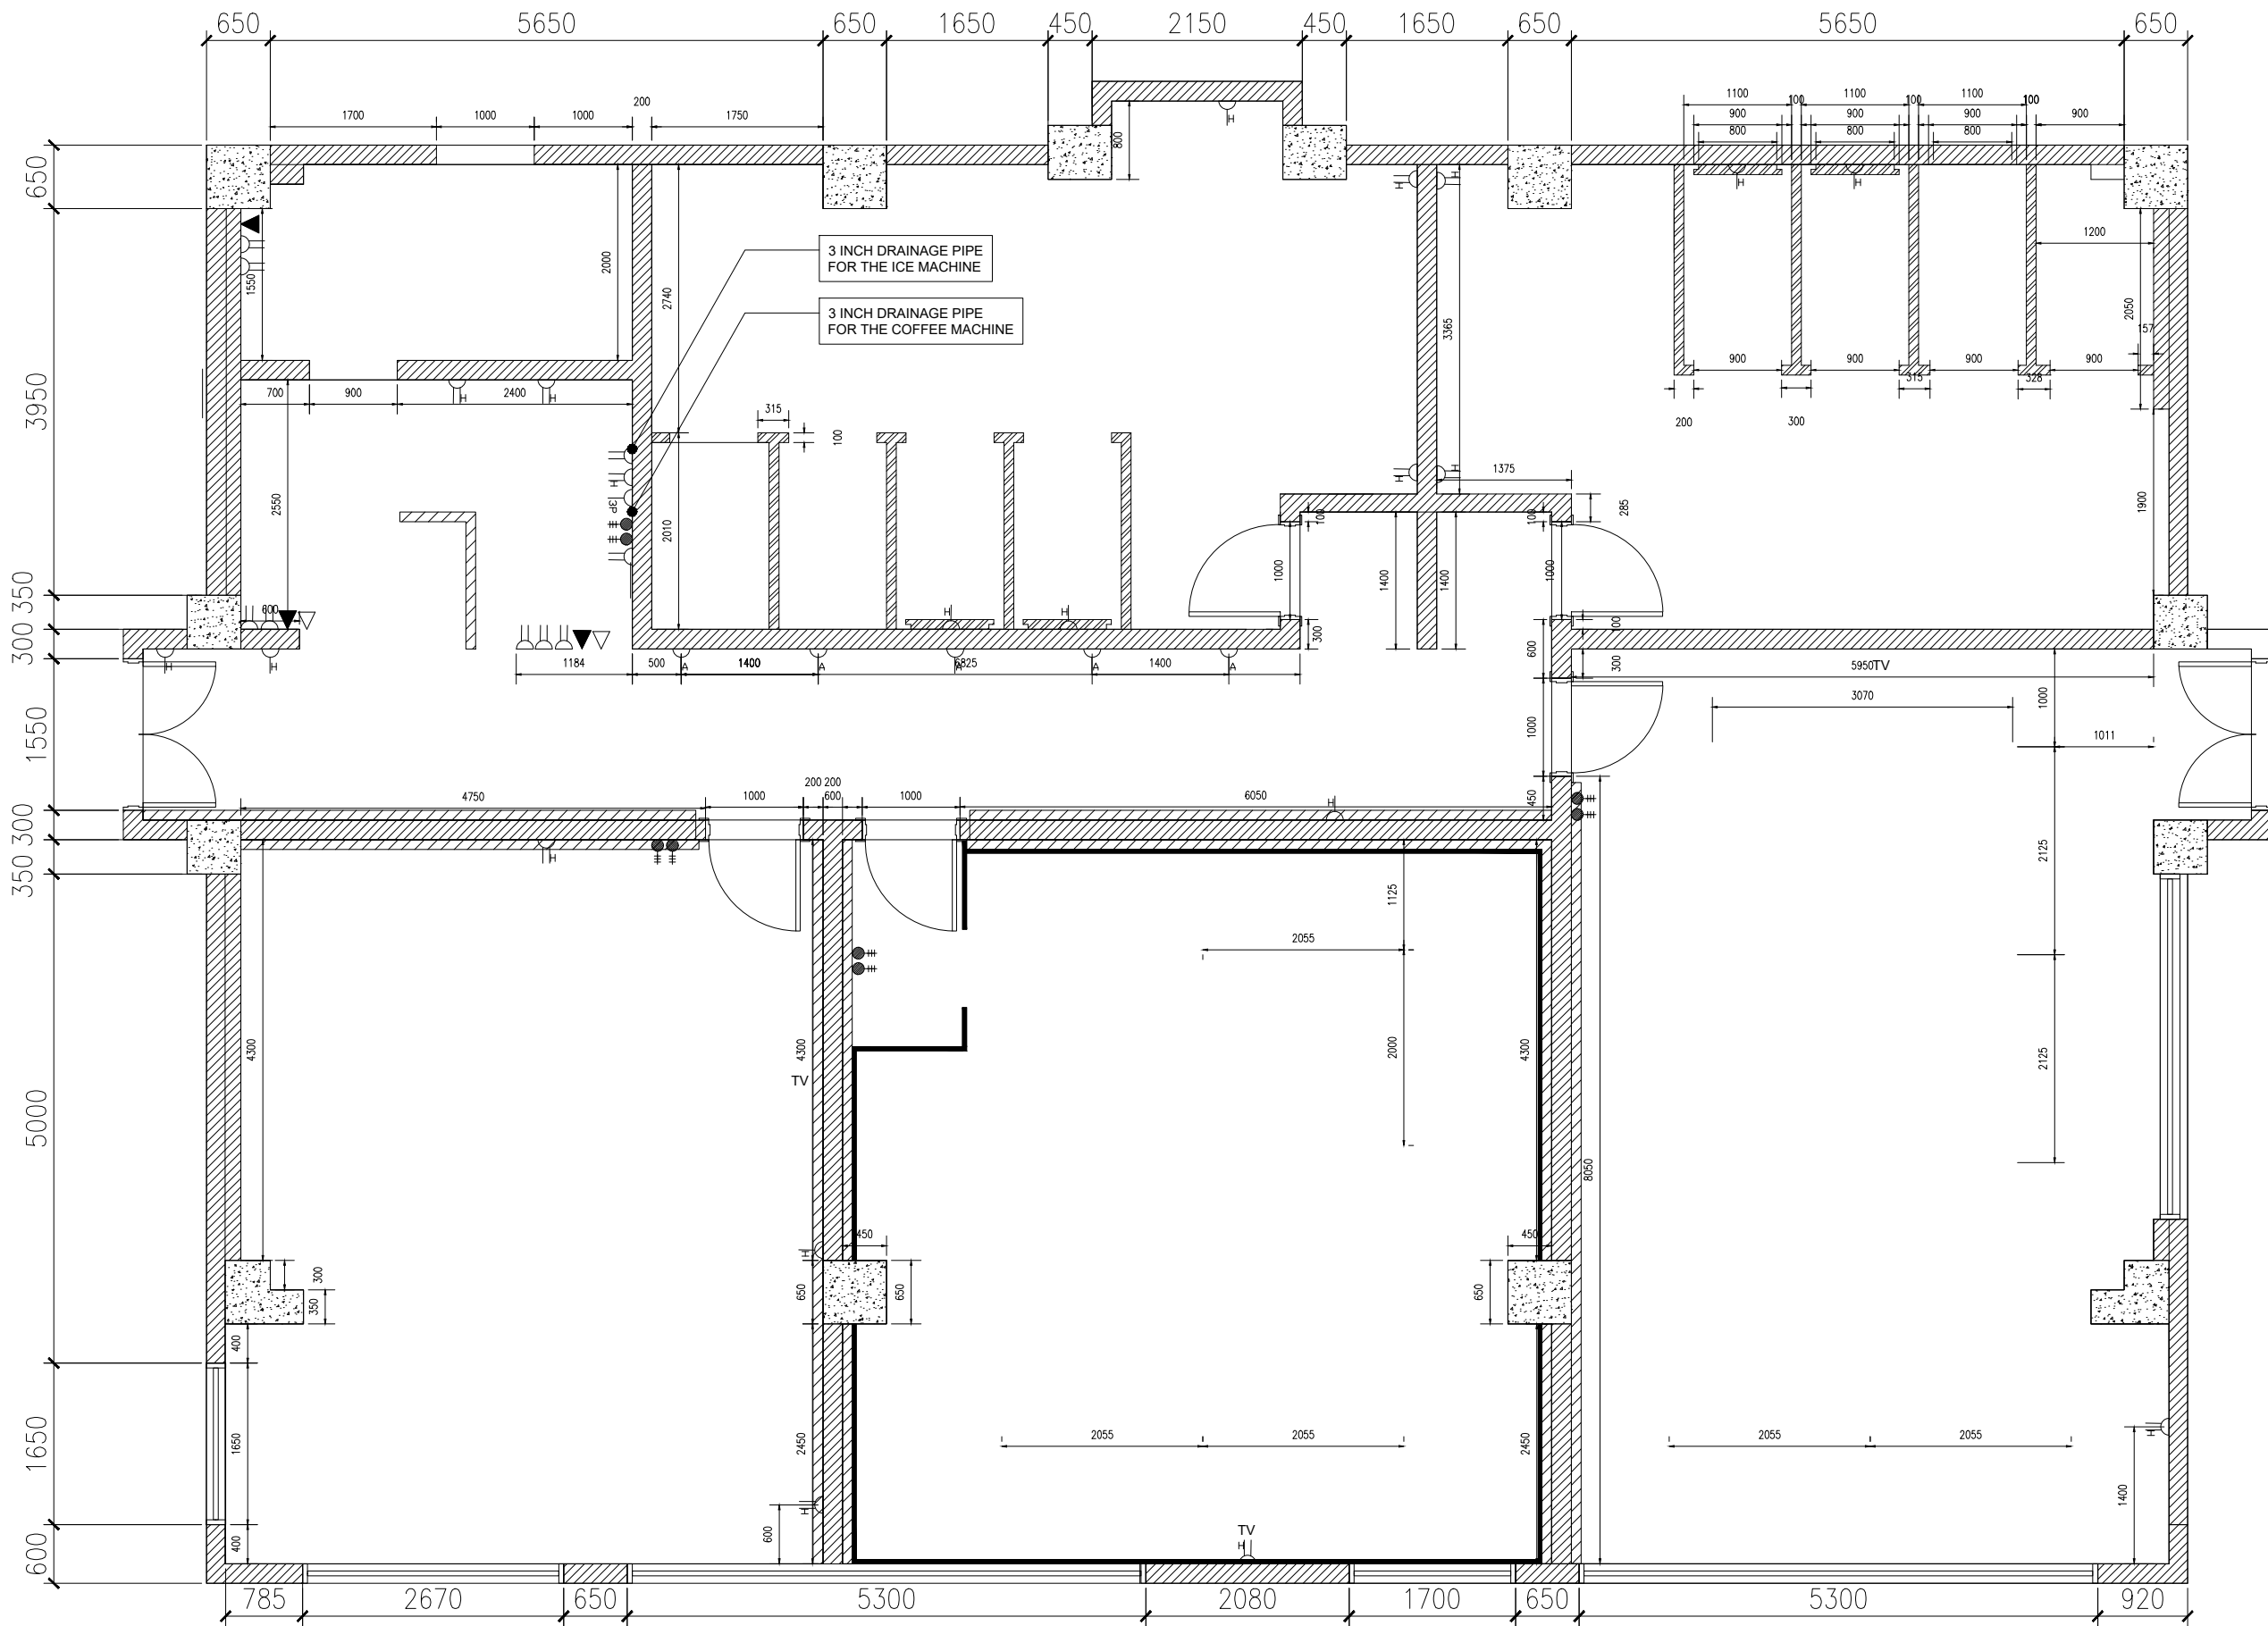

GENERAL NOTES

- 1 Do not scale off this drawing - work to figured dimensions only.
- 2 Check all dimensions and levels on site before commencing work.
- 3 Report any discrepancies to the supervising engineer and obtain instructions.
- 4 Bahrain construction specification applies.
- 5 Contractor to provide necessary sample/mock-up for all the material, finishes as stated for d-interiors approval.

NOTE:

- All dimensions in millimeter unless otherwise stated.
- All lighting fixtures & switches locations to be marked at site for id's approval
- HVAC, Electrical, Plumbing, AV System, Fire Protection, Kitchen Equipment and any related Specialty Works and requirements shall be conformed by the respective duly MEP & Auxiliary Consultant.

LEGEND

| SYMBOL | DESCRIPTION | REF. NO. |
|--------|--|----------|
| | DOUBLE SOCKET -HT. 450MM FROM FFL | |
| | SINGLE SOCKET -HT. 450MM FROM FFL | |
| | SINGLE SOCKET - 3 PHASE -HT. 450MM FROM FFL | |
| | SINGLE SOCKET FLOOR MOUNTED | |
| | SINGLE SOCKET ABOVE CEILING | |
| | DOUBLE SOCKET -HT. 1200 MM FROM FFL | |
| | SINGLE SOCKET -HT. 1700 MM FROM FFL | |
| | DATA SOCKET -HT. 450MM FROM FFL | |
| | TELEPHONE SOCKET -HT. 450 FROM FFL | |

NO. REVISION DATE

CLIENT
ISA ALSHOMLY

PROJECT
DOHA ARAD
MUHARRAQ, KINGDOM of BAHRAIN

DRAWING
FITSPACE GYM


SCALE : AS SHOWN
DATE : 19.09.2024
DESIGNER: AHMED SUBAH
CHECKED :
IS-ID-03

3

ELECTRICAL SMALL POWER

SCALE

1:50

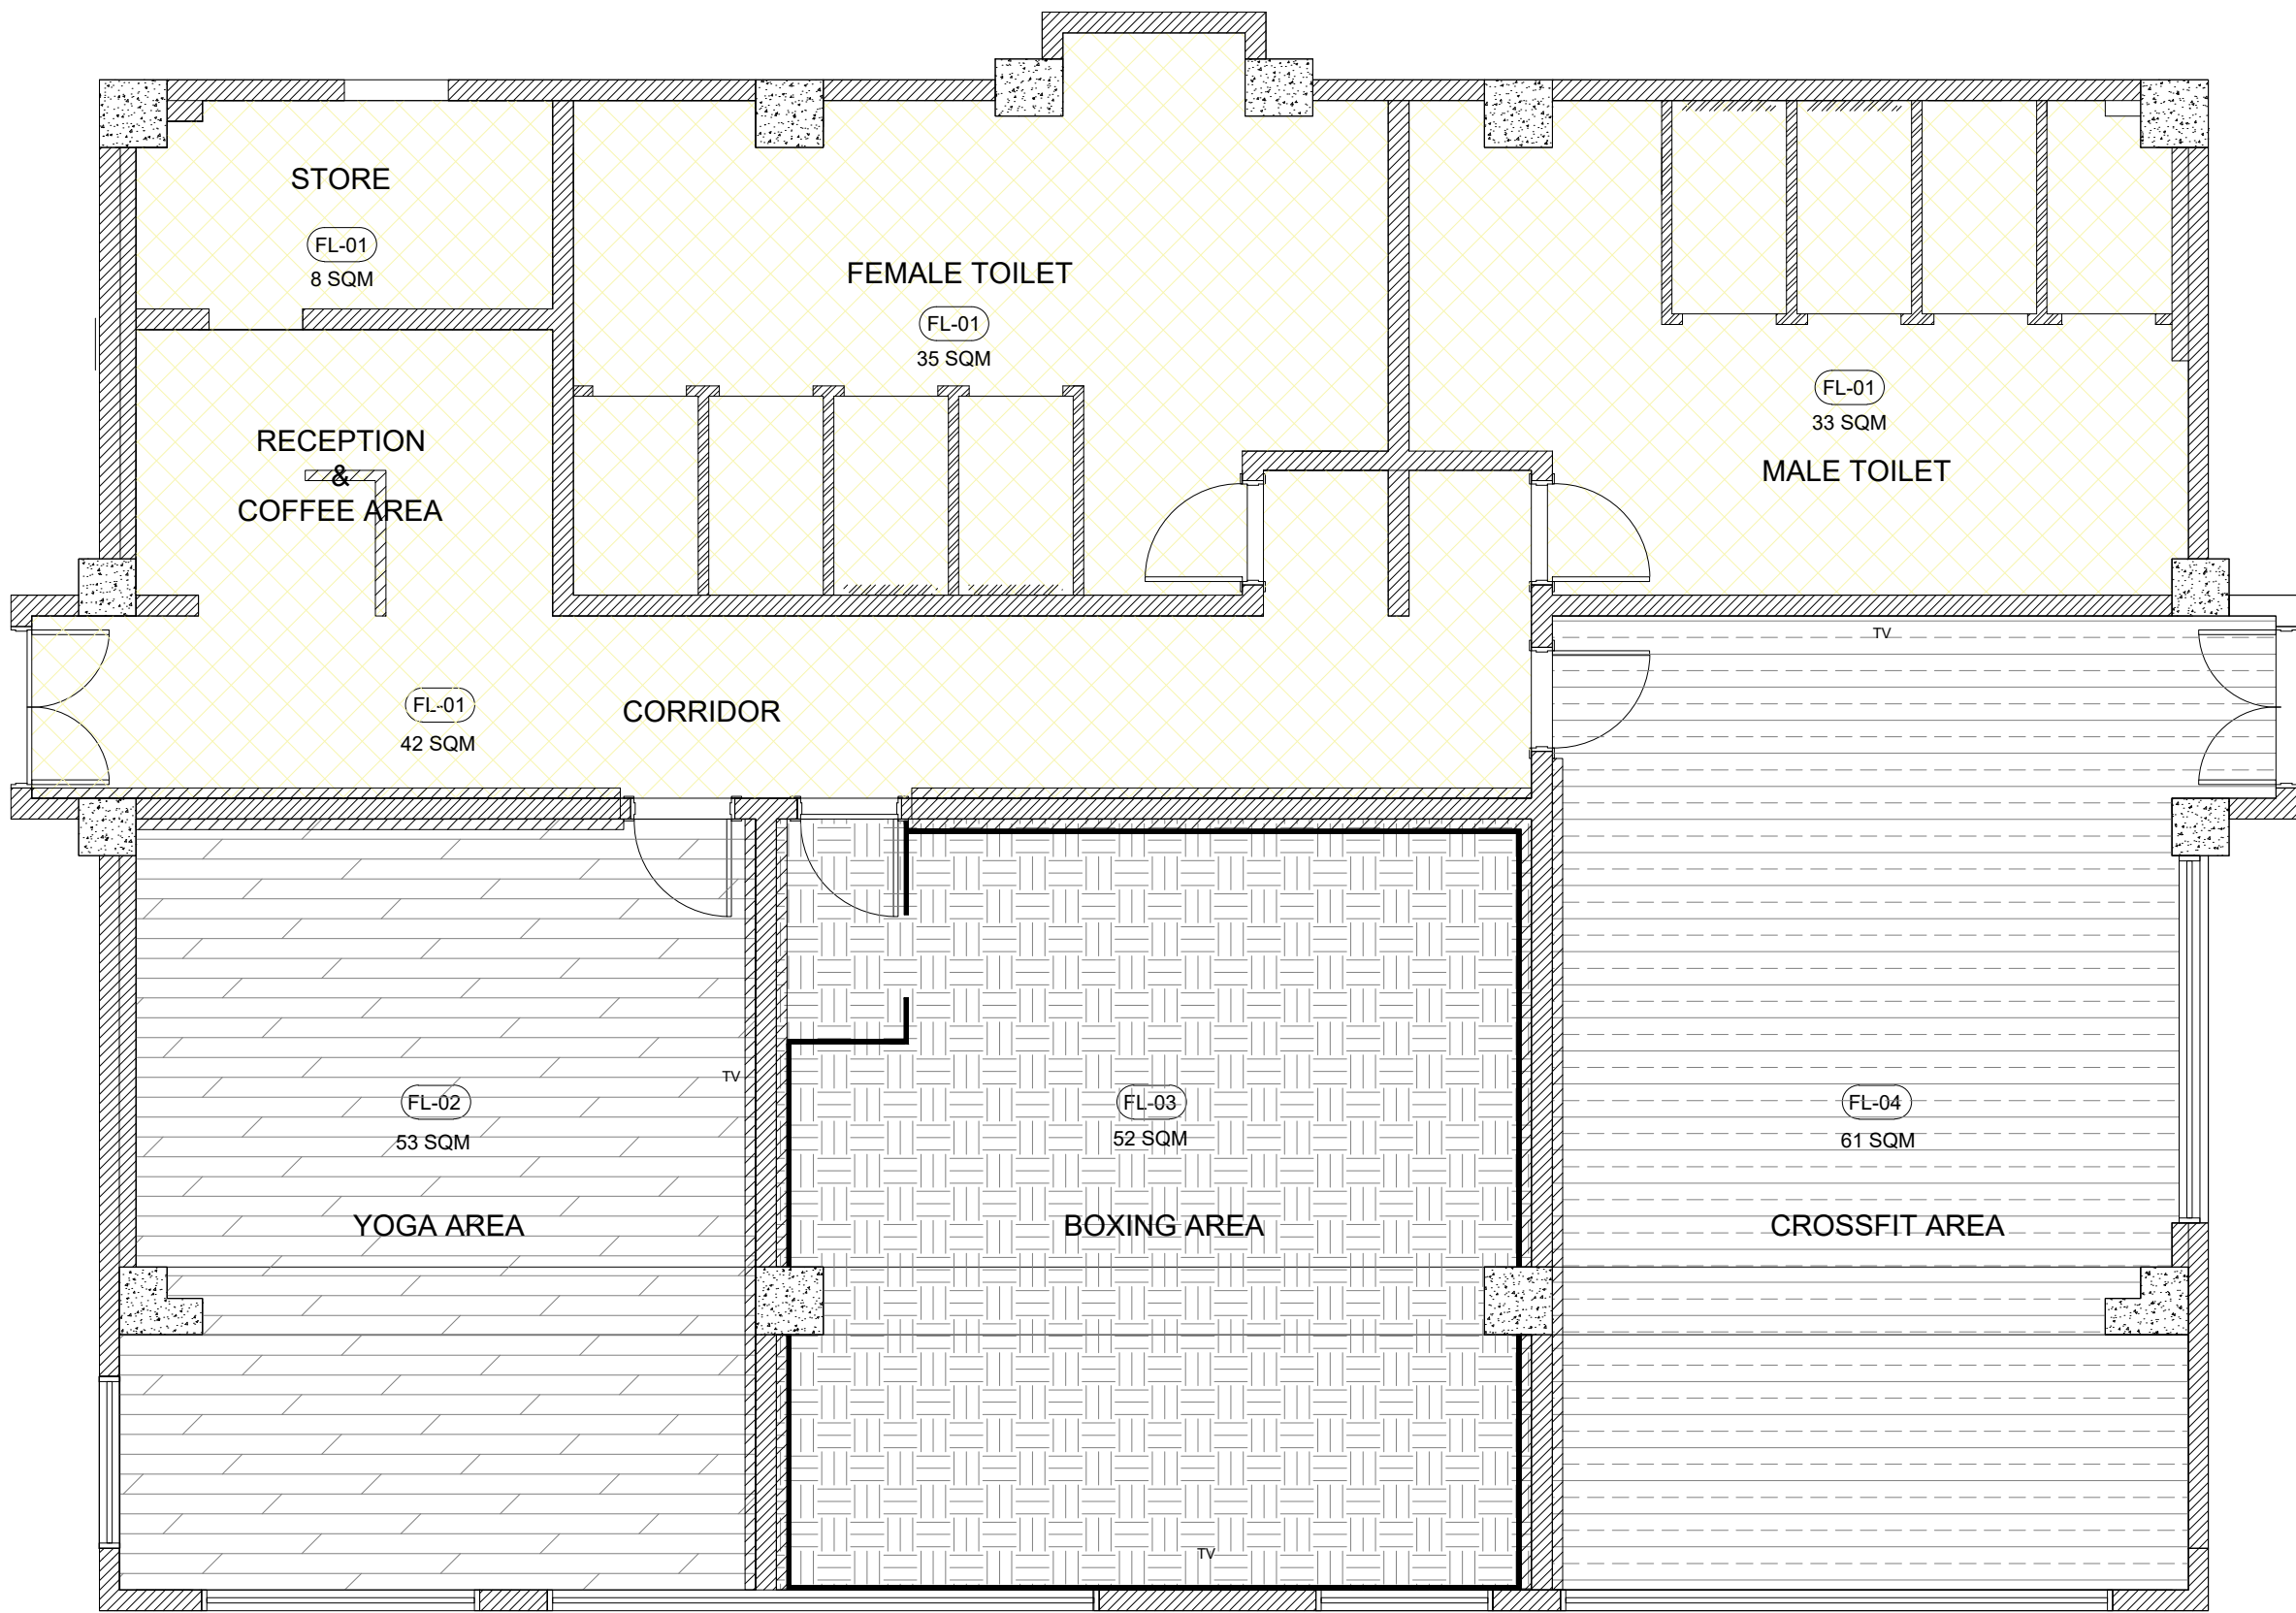

GENERAL NOTES

- 1 Do not scale off this drawing - work to figured dimensions only.
- 2 Check all dimensions and levels on site before commencing work.
- 3 Report any discrepancies to the supervising engineer and obtain instructions.
- 4 Bahrain construction specification applies.
- 5 Contractor to provide necessary sample/mock-up for all the material, finishes as stated for d-interiors approval.

NOTE:

- All dimensions in millimeter unless otherwise stated.
- All lighting fixtures & switches locations to be marked at site for id's approval
- HVAC, Electrical, Plumbing, AV System, Fire Protection, Kitchen Equipment and any related Specialty Works and requirements shall be conformed by the respective duly MEP & Auxilliary Consultant.

FLOOR FINISH LEGEND

| REF. NO. | DESCRIPTION |
|----------|--|
| FL - 01 | PORCELAIN TILE 1200mm x 1200mm x 12mm THK, NATURALE / MATTE FINISH FLORIM, OR EQUAL - AS PER APPROVED SAMPLE & SPECIFICATION |
| FL - 02 | PARQUET FLOORING TILE 900 X 150 X 12mm THK, OR EQUAL - AS PER APPROVED SAMPLE & SPECIFICATION |
| FL - 03 | AS PER APPROVED SAMPLE & SPECIFICATION |
| FL - 04 | AS PER APPROVED SAMPLE & SPECIFICATION |

NO. REVISION DATE

CLIENT

ISA ALSHOMLY

PROJECT

DOHA ARAD
MUHARRAQ, KINGDOM of BAHRAIN

DRAWING

FITSPACE GYM

SCALE : AS SHOWN
DATE : 19.09.2024
DESIGNER : AHMED SUBAH
CHECKED :


IS-ID-04

4


FLOOR PLAN

SCALE

1:50

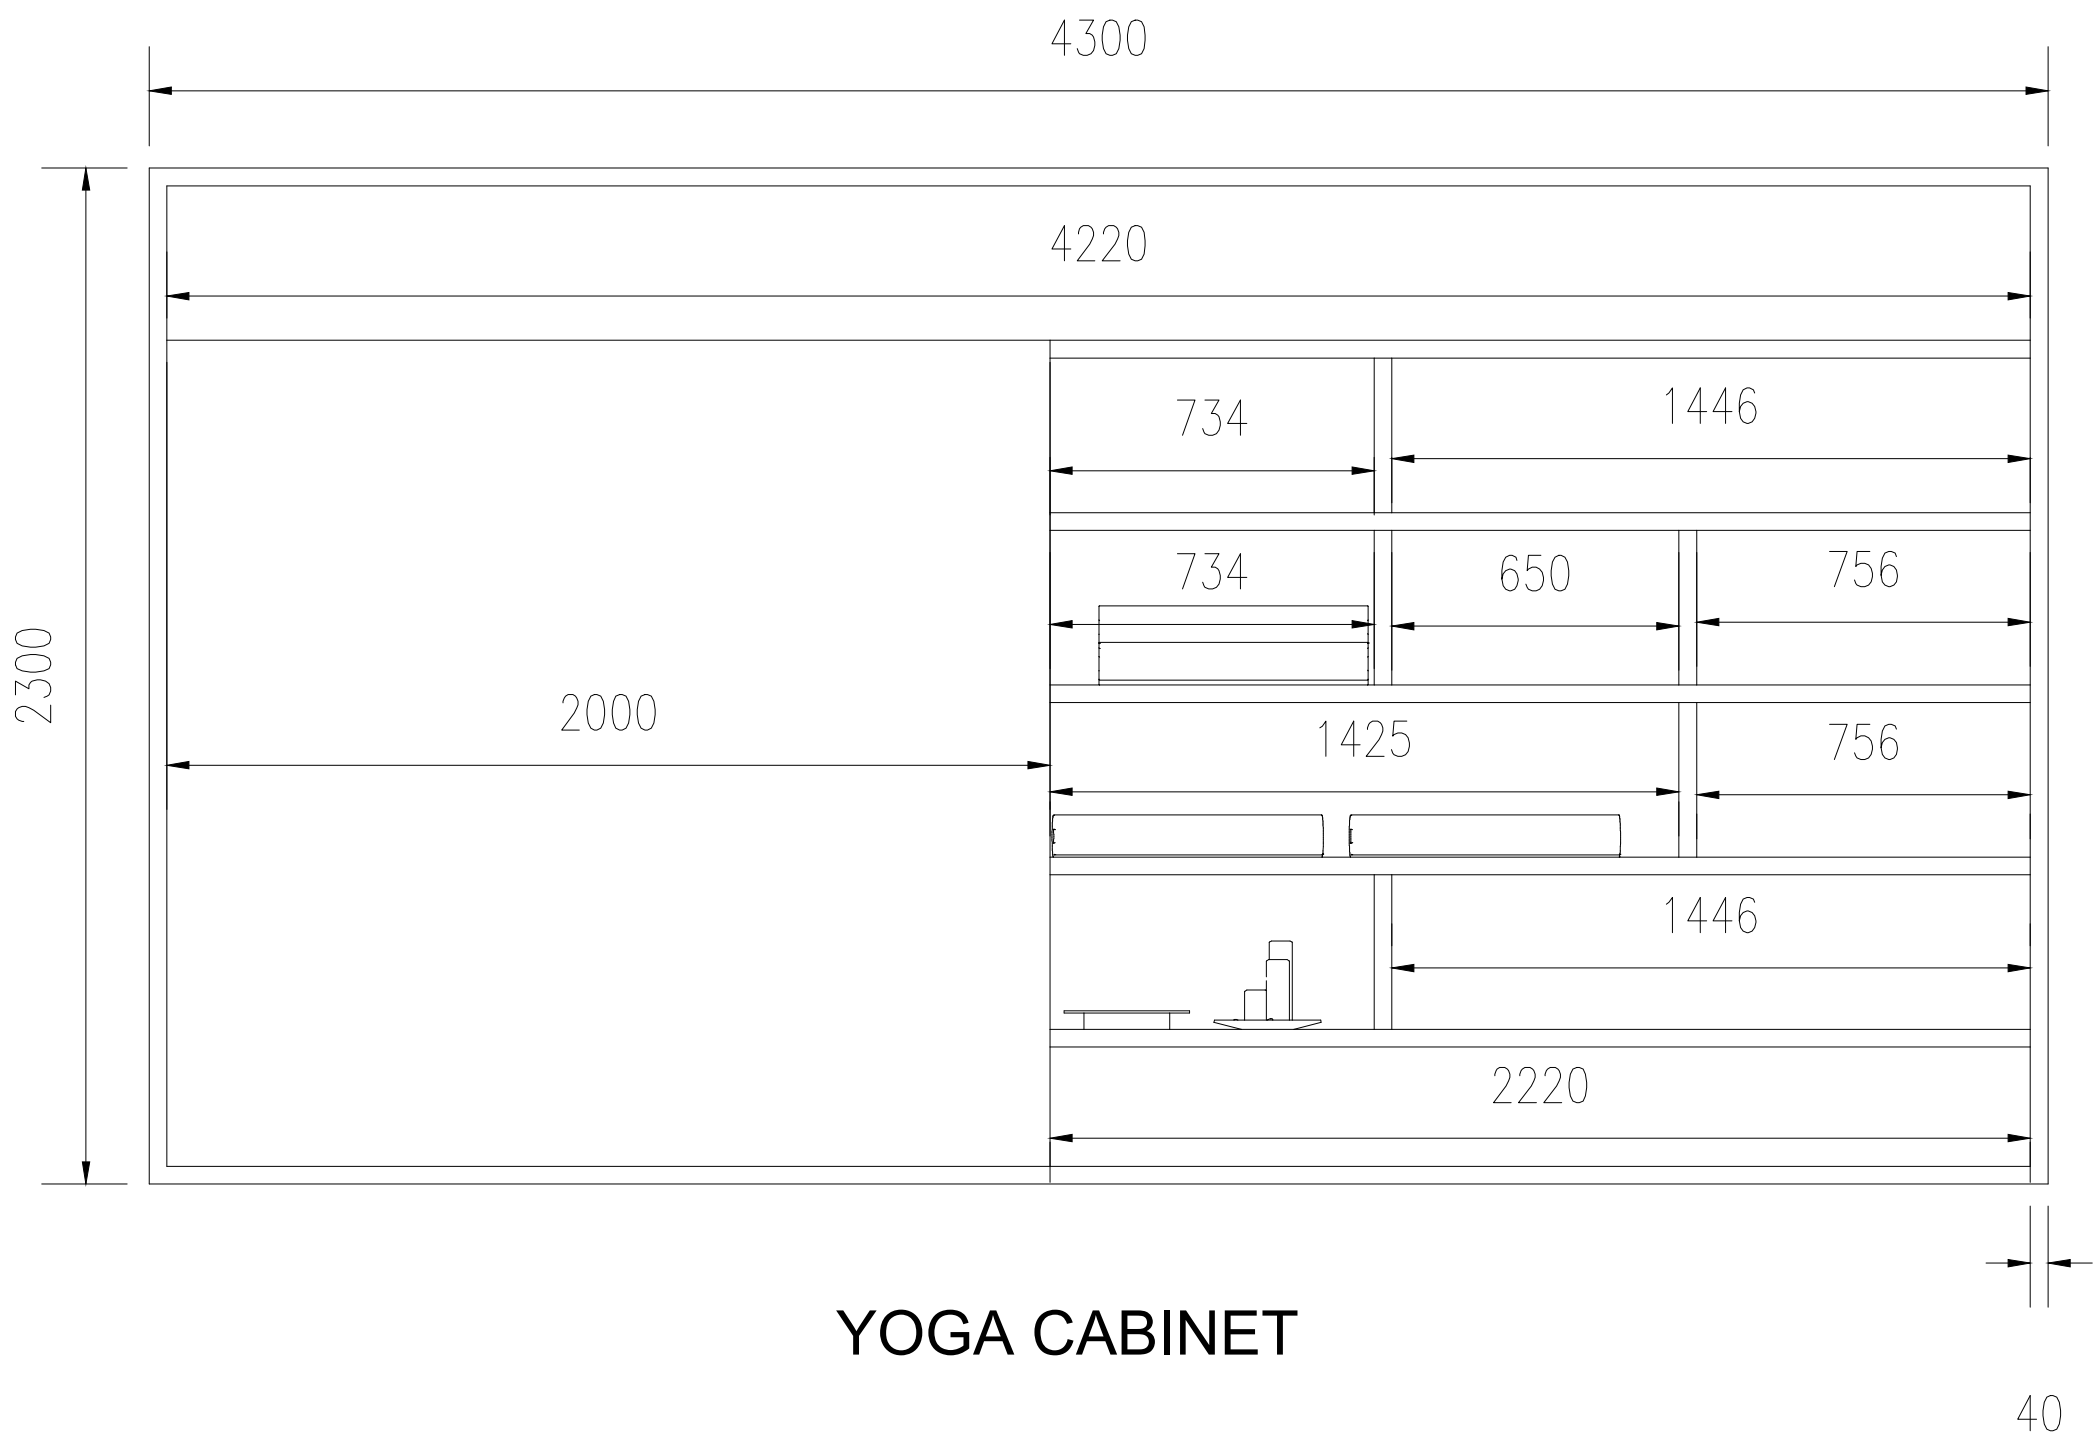

YOGA CABINET

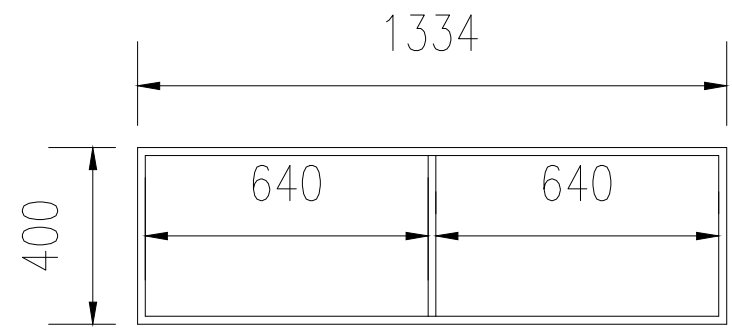

BOXING STORE


GENERAL NOTES

- 1 Do not scale off this drawing - work to figured dimensions only.
- 2 Check all dimensions and levels on site before commencing work.
- 3 Report any discrepancies to the supervising engineer and obtain instructions.
- 4 Bahrain construction specification applies.
- 5 Contractor to provide necessary sample/mock-up for all the material, finishes as stated for d-interiors approval.

NOTE:

- All dimensions in millimeter unless otherwise stated.
- All lighting fixtures & switches locations to be marked at site for id's approval
- HVAC, Electrical, Plumbing, AV System, Fire Protection,Kitchen Equipment and any related Specialty Works and requirements shall be conformed by the respective duly MEP & Auxilliary Consultant.

| | | |
|---|----------|------|
| | | |
| | | |
| | | |
| NO. | REVISION | DATE |
| CLIENT | | |
| ISA ALSHOMLY | | |
| PROJECT | | |
| DOHA ARAD MUHARRAQ, KINGDOM of BAHRAIN | | |
| DRAWING | | |
| FITSPACE GYM | | |
| SCALE : AS SHOWN | IS-ID-05 | |
| DATE : 19.09.2024 | | |
| DESIGNER: AHMED SUBAH | | |
| CHECKED : | | |

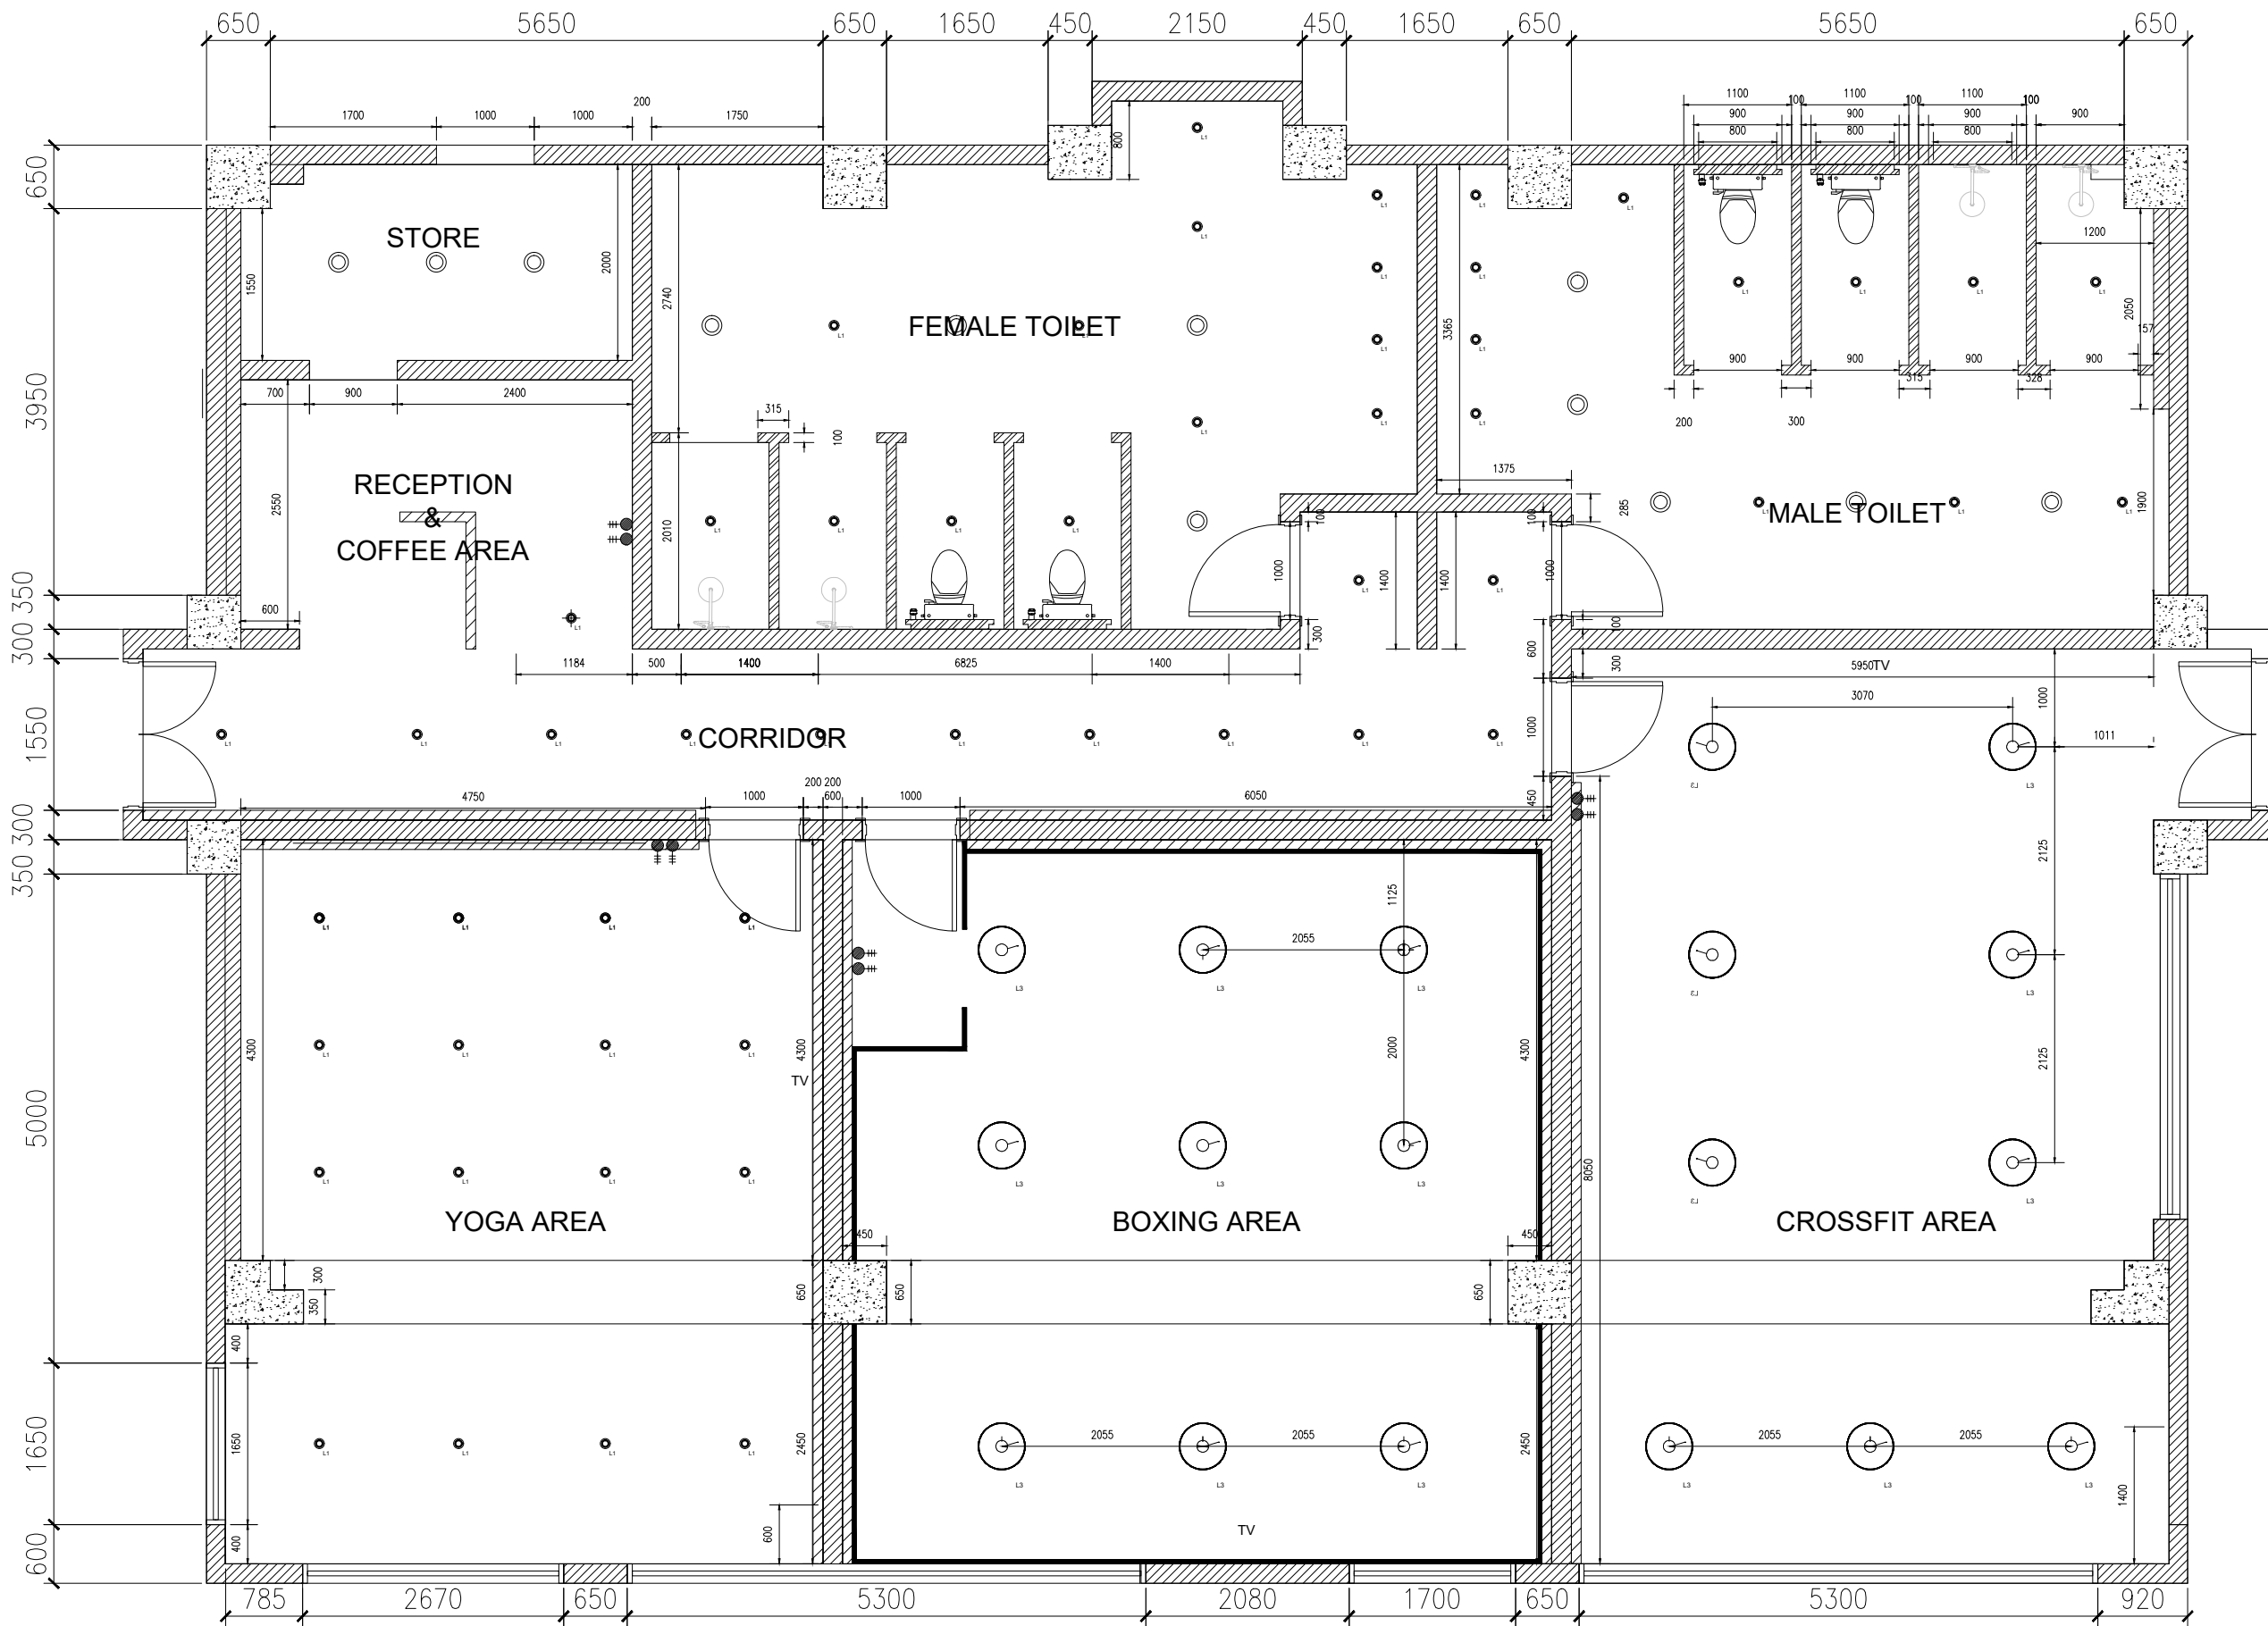

GENERAL NOTES

- 1 Do not scale off this drawing - work to figured dimensions only.
- 2 Check all dimensions and levels on site before commencing work.
- 3 Report any discrepancies to the supervising engineer and obtain instructions.
- 4 Bahrain construction specification applies.
- 5 Contractor to provide necessary sample/mock-up for all the material, finishes as stated for d-interiors approval.

NOTE:

- All dimensions in millimeter unless otherwise stated.
- All lighting fixtures & switches locations to be marked at site for id's approval
- HVAC, Electrical, Plumbing, AV System, Fire Protection, Kitchen Equipment and any related Specialty Works and requirements shall be conformed by the respective duly MEP & Auxiliary Consultant.

LEGEND

| REF. | SYMBOL | DESCRIPTION |
|------|--------|---|
| L1 | | 3 INCH SPOTLIGHT |
| L2 | | 8 INCH DOWN LIGHT (AS PER APPROVED SAMPLE & SPECS.) |
| L3 | | (AS PER APPROVED SAMPLE & SPECS.) |
| L4 | | |
| L5 | | |
| L6 | | |
| L7 | | |
| L8 | | |

NO. REVISION DATE

CLIENT
ISA ALSHOMLY

PROJECT
DOHA ARAD
MUHARRAQ, KINGDOM OF BAHRAIN

DRAWING
FITSPACE GYM



SCALE : AS SHOWN
DATE : 19.09.2024
DESIGNER: AHMED SUBAH
CHECKED :
IS-ID-06

6

LIGHTING PLAN

SCALE

1:50

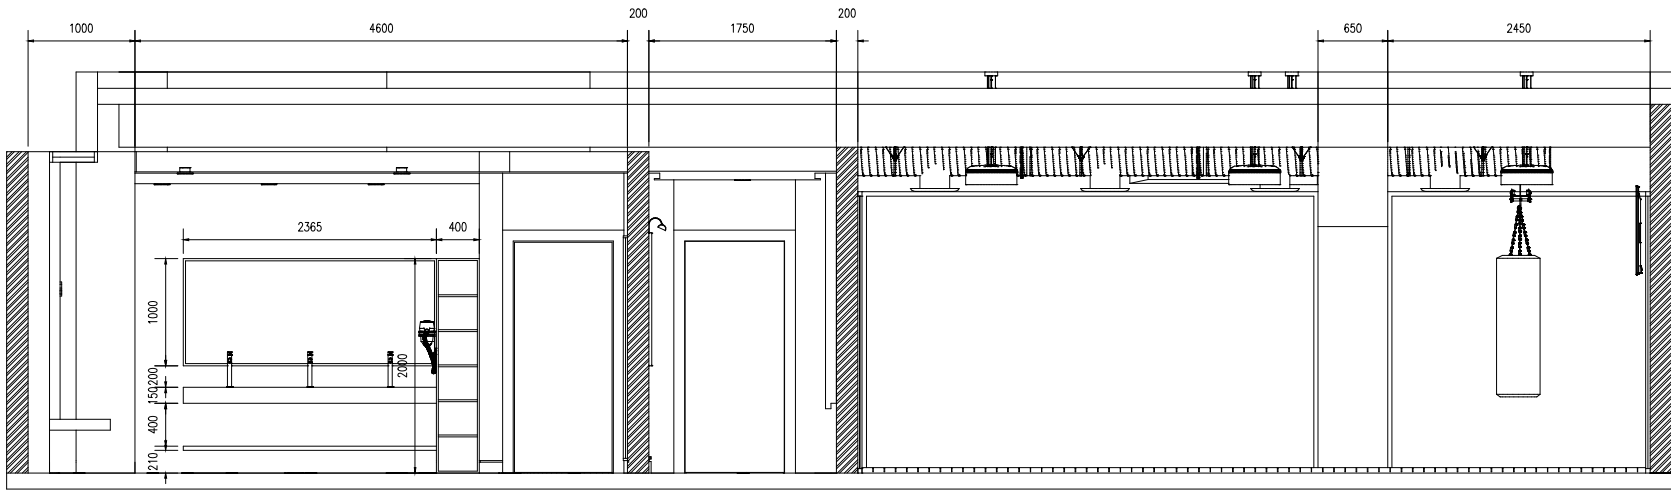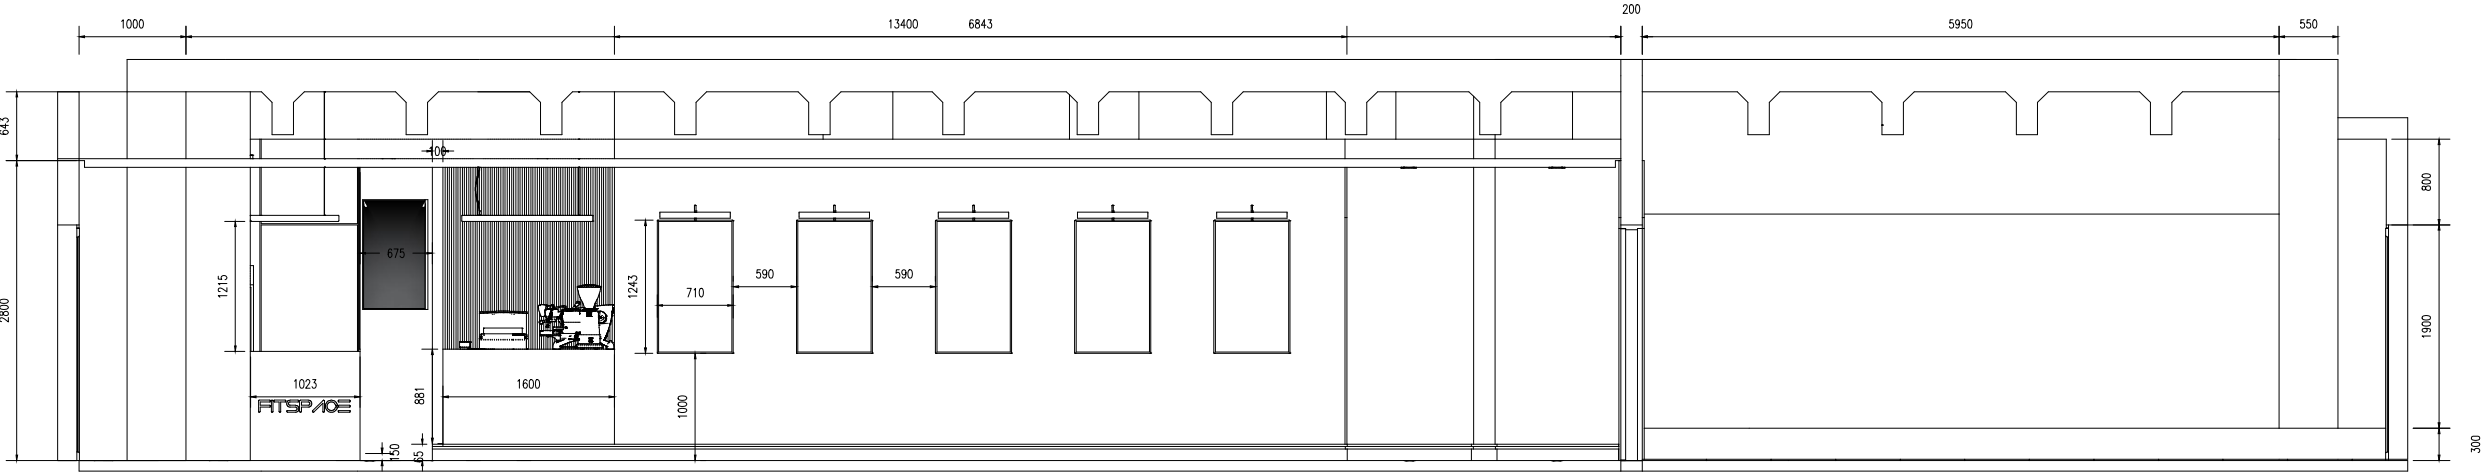

GENERAL NOTES

- 1 Do not scale off this drawing - work to figured dimensions only.
- 2 Check all dimensions and levels on site before commencing work.
- 3 Report any discrepancies to the supervising engineer and obtain instructions.
- 4 Bahrain construction specification applies.
- 5 Contractor to provide necessary sample/mock-up for all the material, finishes as stated for d-interiors approval.

NOTE:

- All dimensions in millimeter unless otherwise stated.
- All lighting fixtures & switches locations to be marked at site for id's approval
- HVAC, Electrical, Plumbing, AV System, Fire Protection,Kitchen Equipment and any related Specialty Works and requirements shall be conformed by the respective duly MEP & Auxilliary Consultant.

NO. REVISION DATE

CLIENT

ISA ALSHOMLY

PROJECT

DOHA ARAD
MUHARRAQ, KINGDOM of BAHRAIN

DRAWING

FITSPACE GYM

SCALE : AS SHOWN
DATE : 19.09.2024
DESIGNER: AHMED SUBAH
CHECKED :


IS-ID-07

7

SECTION-A-B

SCALE

1:50

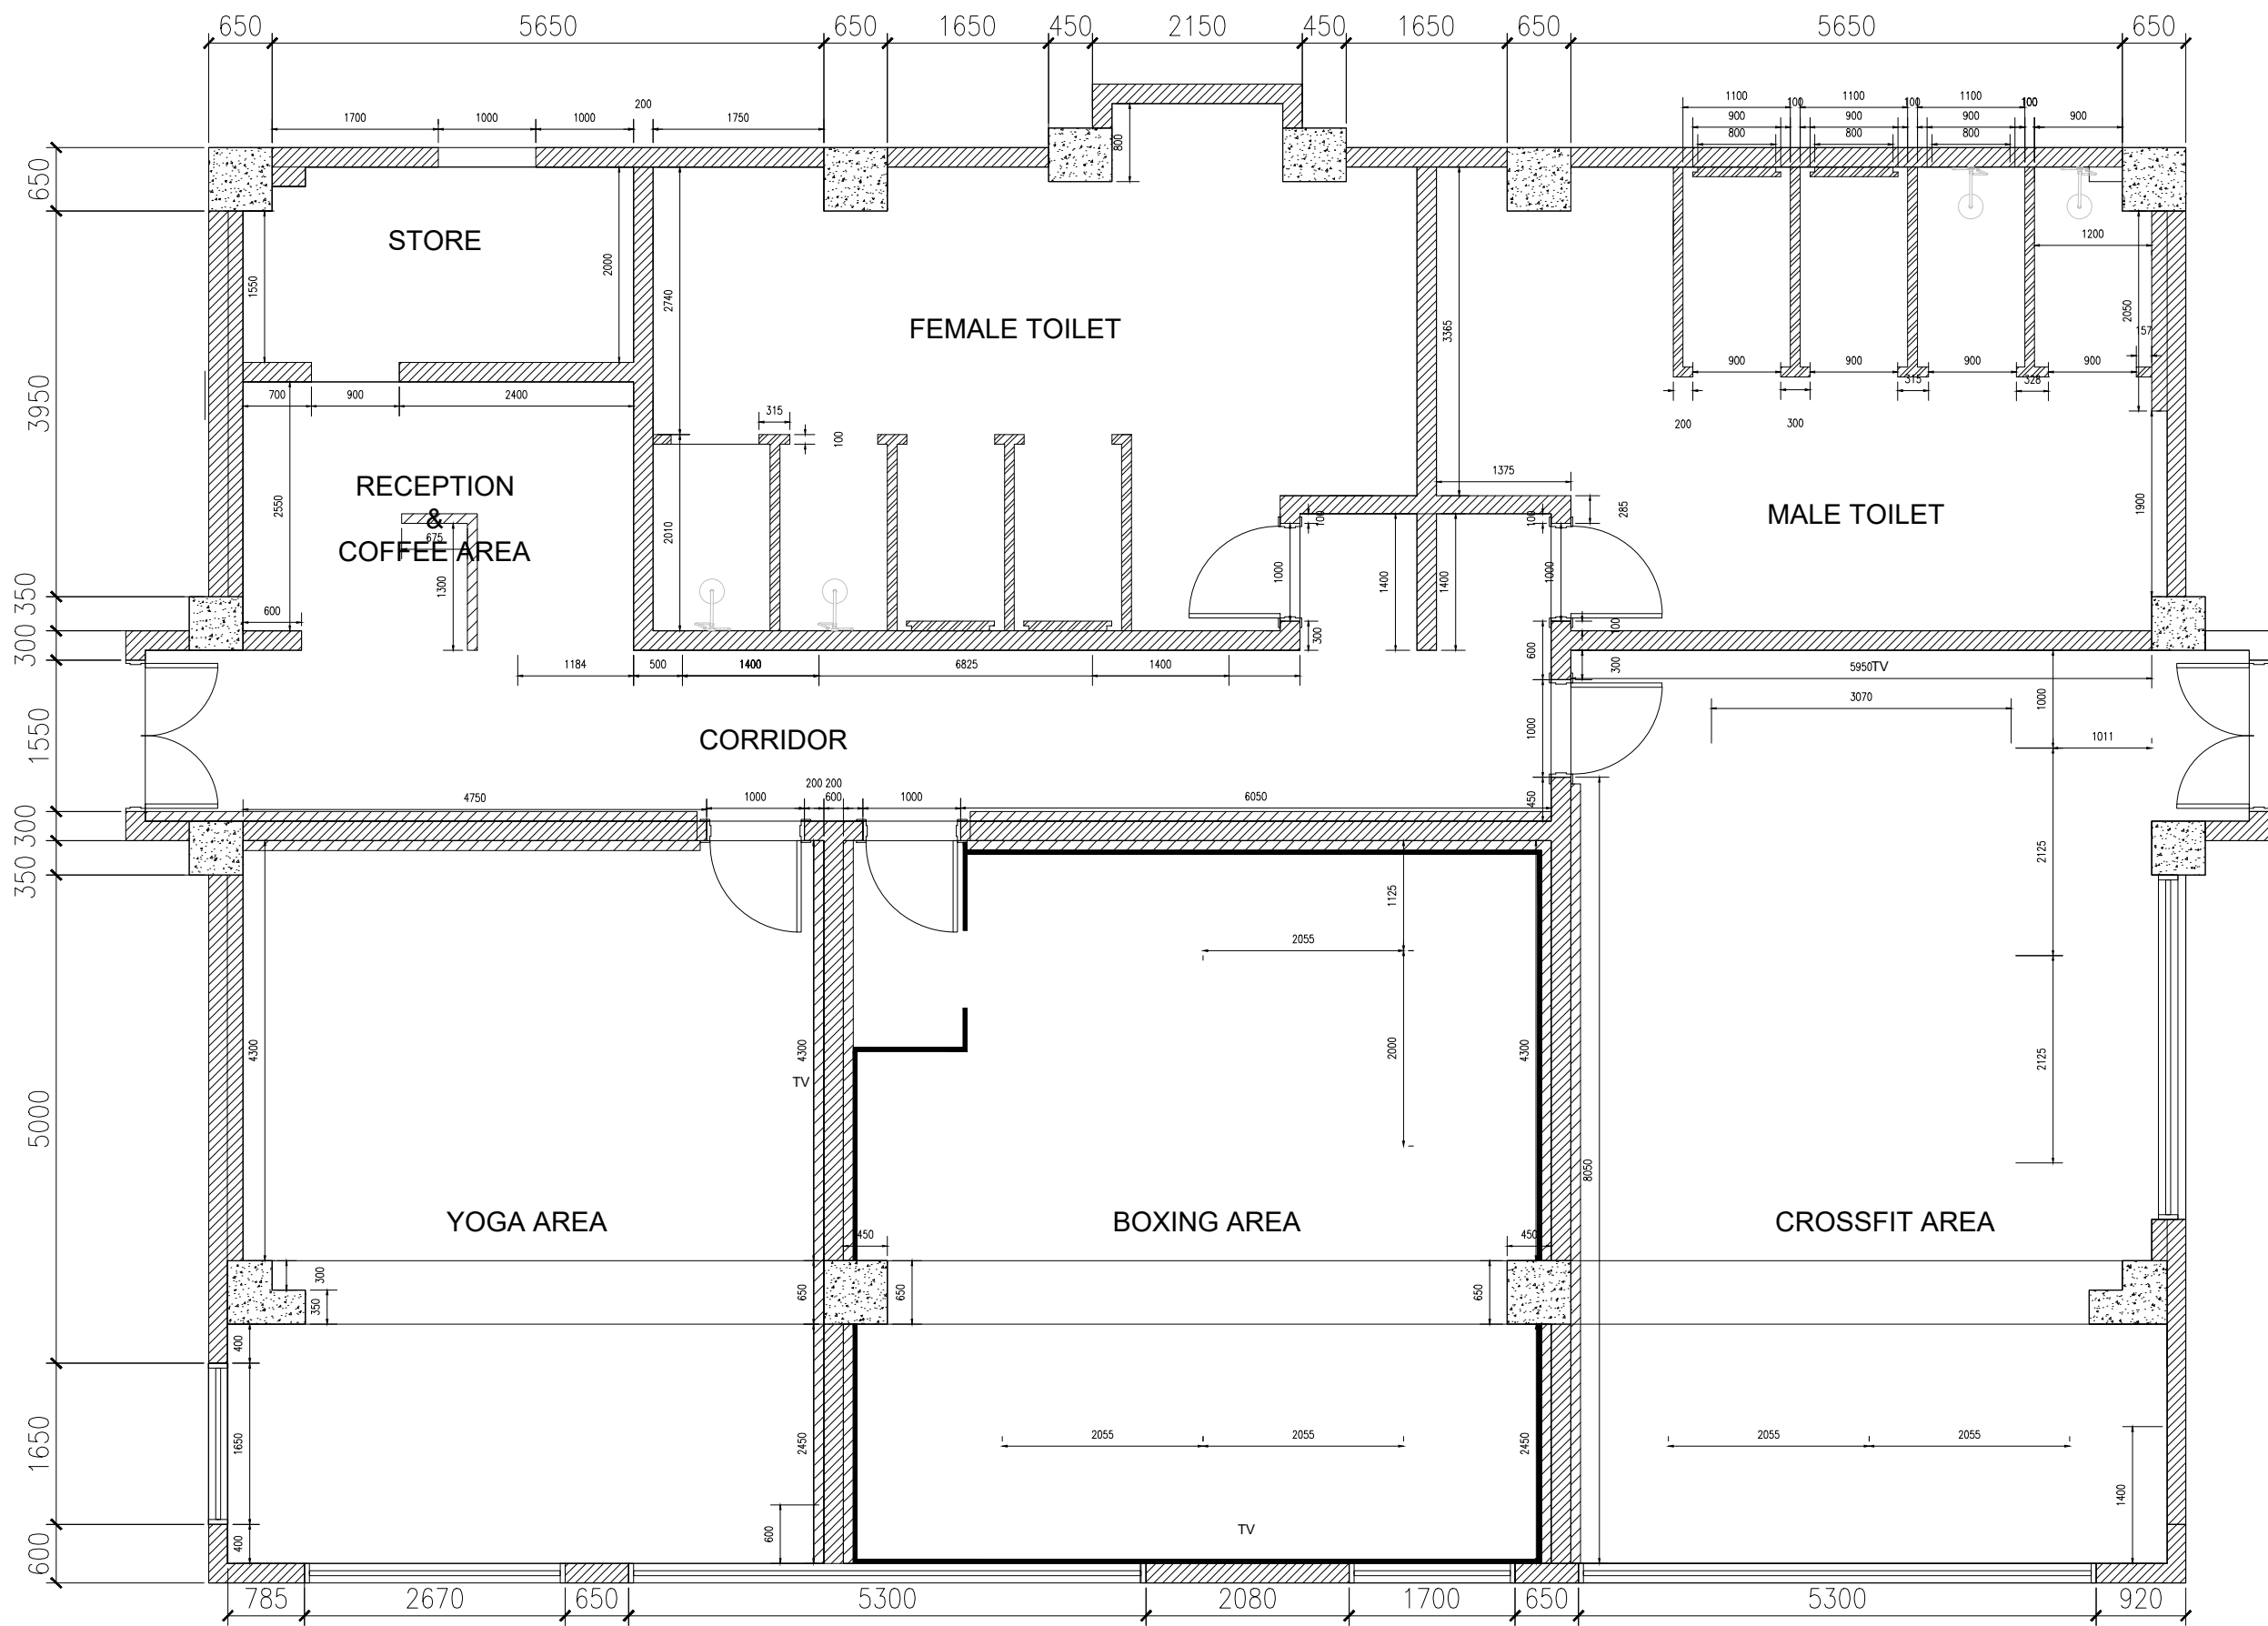

GENERAL NOTES

- 1 Do not scale off this drawing - work to figured dimensions only.
- 2 Check all dimensions and levels on site before commencing work.
- 3 Report any discrepancies to the supervising engineer and obtain instructions.
- 4 Bahrain construction specification applies.
- 5 Contractor to provide necessary sample/mock-up for all the material, finishes as stated for d-interiors approval.

NOTE:

- All dimensions in millimeter unless otherwise stated.
- All lighting fixtures & switches locations to be marked at site for id's approval
- HVAC, Electrical, Plumbing, AV System, Fire Protection, Kitchen Equipment and any related Specialty Works and requirements shall be conformed by the respective duly MEP & Auxiliary Consultant.

NO. REVISION DATE

CLIENT
ISA ALSHOMLY

PROJECT
DOHA ARAD
MUHARRAQ, KINGDOM of BAHRAIN

DRAWING
FITSPACE GYM

SCALE : AS SHOWN
DATE : 19.09.2024
DESIGNER : AHMED SUBAH
CHECKED :
IS-ID-08

8

GYPSUM WALL

SCALE

1:50

GENERAL NOTES

- 1

Do not scale off this drawing - work to figured dimensions only.
- 2

Check all dimensions and levels on site before commencing work.
- 3



Report any discrepancies to the supervising engineer and obtain instructions.
- 4

Bahrain construction specification applies.
- 5

Contractor to provide necessary sample/mock-up for all the material, finishes as stated for d-interiors approval.

NOTE:

- All dimensions in millimeter unless otherwise stated.
- All lighting fixtures & switches locations to be marked at site for id's approval
- HVAC, Electrical, Plumbing, AV System, Fire Protection,Kitchen Equipment and any related Specialty Works and requirements shall be conformed by the respective duly MEP & Auxilliary Consultant.

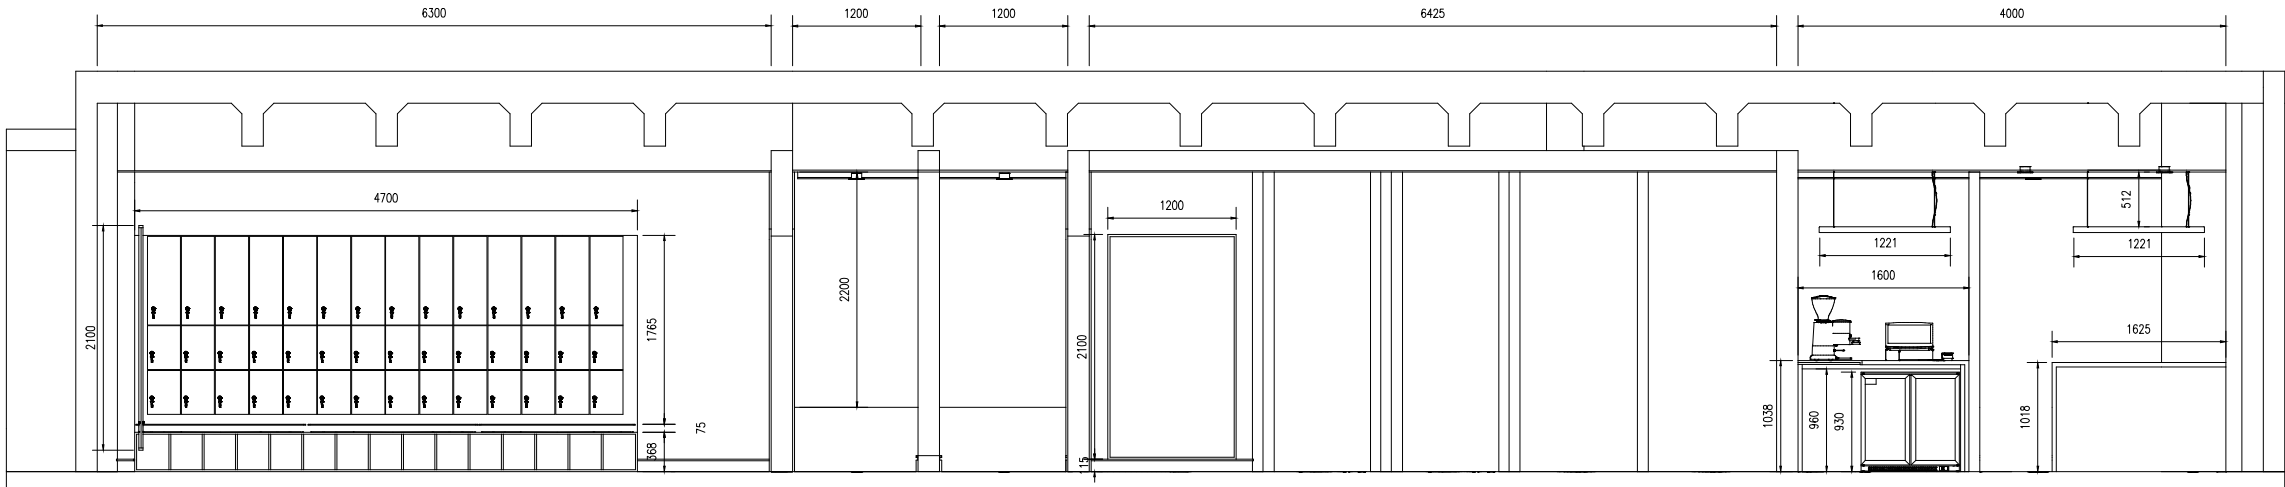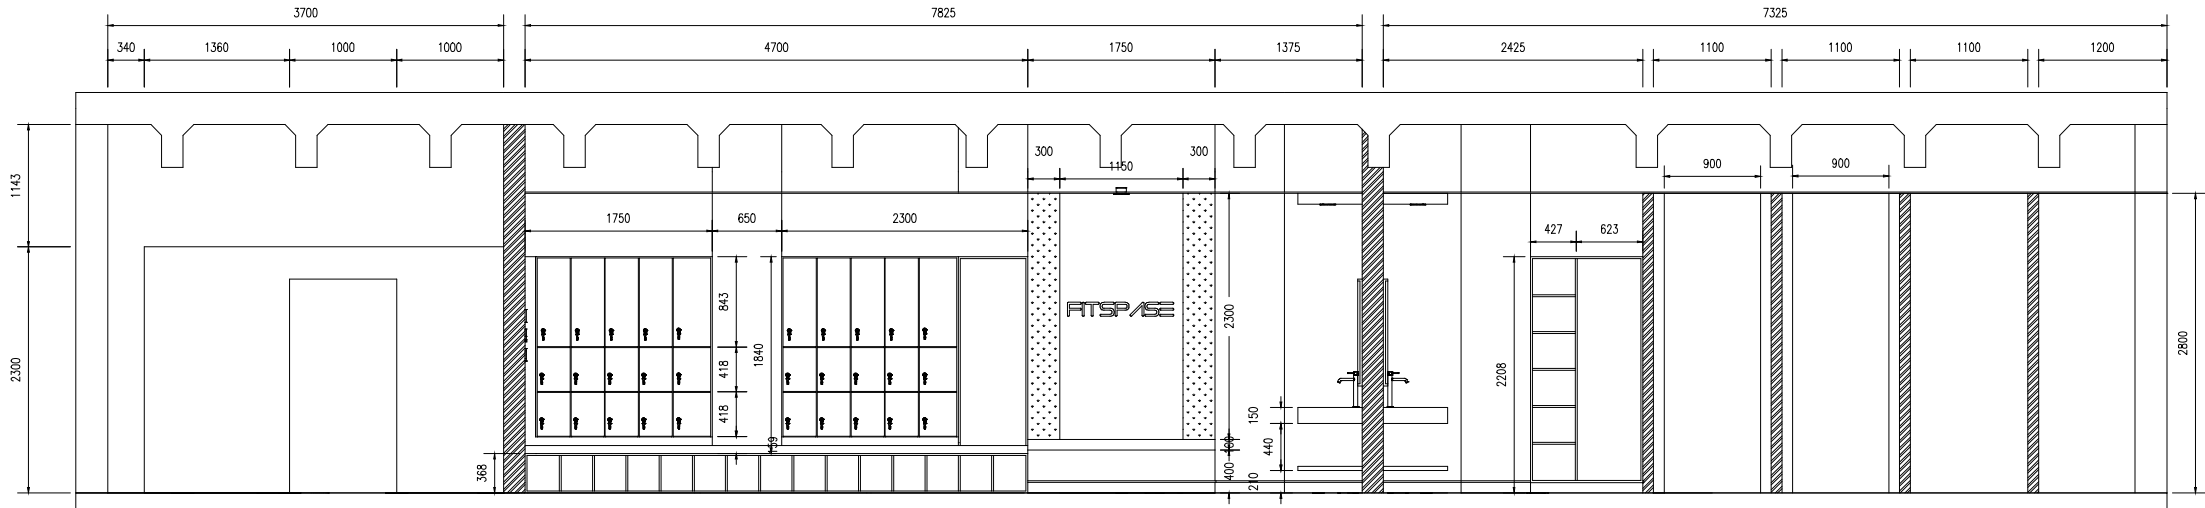

NO. REVISION DATE

CLIENT
ISA ALSHOMLY

PROJECT
DOHA ARAD
MUHARRAQ, KINGDOM of BAHRAIN

DRAWING
FITSPACE GYM

SCALE : AS SHOWN
DATE : 19.09.2024
DESIGNER : AHMED SUBAH
CHECKED :

IS-ID-09

9

SECTION-C-D

SCALE

1:50